


- GENERAL NOTES:**
1. THIS DRAWING IS TO BE READ IN CONJUNCTION WITH ALL RELEVANT ARCHITECTS AND STRUCTURAL ENGINEERS CONSTRUCTION ISSUE DRAWINGS, FIRE CERTIFICATE & FIRE DRAWINGS, ALONG WITH THE CONSULTANTS MECHANICAL AND ELECTRICAL SPECIFICATIONS AND ANY OTHER DOCUMENTATION.
 2. DO NOT SCALE FROM THIS DRAWING. THIS DRAWING IS REPRESENTATIVE ONLY. ALL DIMENSIONS ARE IN MILLIMETERS (mm), UNLESS OTHERWISE STATED. USE THE FIGURED DIMENSIONS WHEN SHOWN.
 3. THE EXACT LOCATION OF SERVICES AND FITTINGS TO BE AGREED ON SITE WITH THE ARCHITECT AND/OR MECHANICAL OR STRUCTURAL ENGINEER PRIOR TO THEIR INSTALLATION.
 4. THE MECHANICAL AND ELECTRICAL SERVICES ARE TO BE CO-ORDINATED WITH ALL OTHER TRADES AND TO BE AGREED ON SITE PRIOR TO THEIR INSTALLATION. THE CONTRACTOR SHALL ALLOW FOR THE SETTING OUT AND INSTALLATION AROUND ALL OBSTRUCTIONS. ADDITIONAL COSTS INCURRED BY THE CONTRACTOR DUE TO THE LACK OF CO-ORDINATION WILL NOT BE ENTERTAINED.
 5. CONNECTIONS TO ALL EQUIPMENT TO BE MADE BY THE CONTRACTOR.
 6. FIRE/ SMOKE DAMPERS, FIRE COLLAR/ SLEEVES, INTUMESCENT PUTTY AND FIRE BARRIERS ARE TO BE INSTALLED WHERE DUCTING, PIPEWORK, CABLES, CONTAINMENT AND ANY OTHER SERVICES PASS THROUGH A FIRE WALL/ COMPARTMENT OR FLOOR.
 7. ANY DISCREPANCIES BETWEEN THIS DRAWING AND ON SITE CONDITIONS MUST BE REPORTED TO RENAISSANCE ENGINEERING LTD. IMMEDIATELY. ANY CHANGES FROM THIS DESIGN DRAWING MUST BE AGREED WITH THE ENGINEER IN WRITING. A FAILURE TO GAIN THIS APPROVAL COULD LEAD TO DIFFICULTY IN APPROVING PAYMENT FOR THE VARIATION(S).
 8. INSTALLATION/ CONSTRUCTION/ AS-BUILT DRAWINGS TO BE PREPARED WITH REFERENCE TO THE LATEST ARCHITECTS AND STRUCTURAL ENGINEERS CONSTRUCTION ISSUE DRAWINGS AND LATEST FIRE CERTIFICATE DRAWINGS.
 9. ALL WORKS TO COMPLY WITH THE NATIONAL CODE OF PRACTICE FOR CUSTOMER INTERFACE 4th EDITION 2008.

- LIGHTING SERVICES LEGEND:**
- A ALVA 28W ROAD LANTERN
 - B NICEA 14W BOLLARD
 - C Eta B 14W SURFACE LUMINAIRE
 - CE Eta B 14W SURFACE LUMINAIRE c/w INTEGRAL EMERGENCY PACK
 - D IPONTE 12W WALL-MOUNTED LUMINAIRE
 - DE IPONTE 12W WALL-MOUNTED LUMINAIRE c/w INTEGRAL EMERGENCY PACK
 - F ATLAS M 19W IN-GROUND UPLIGHT

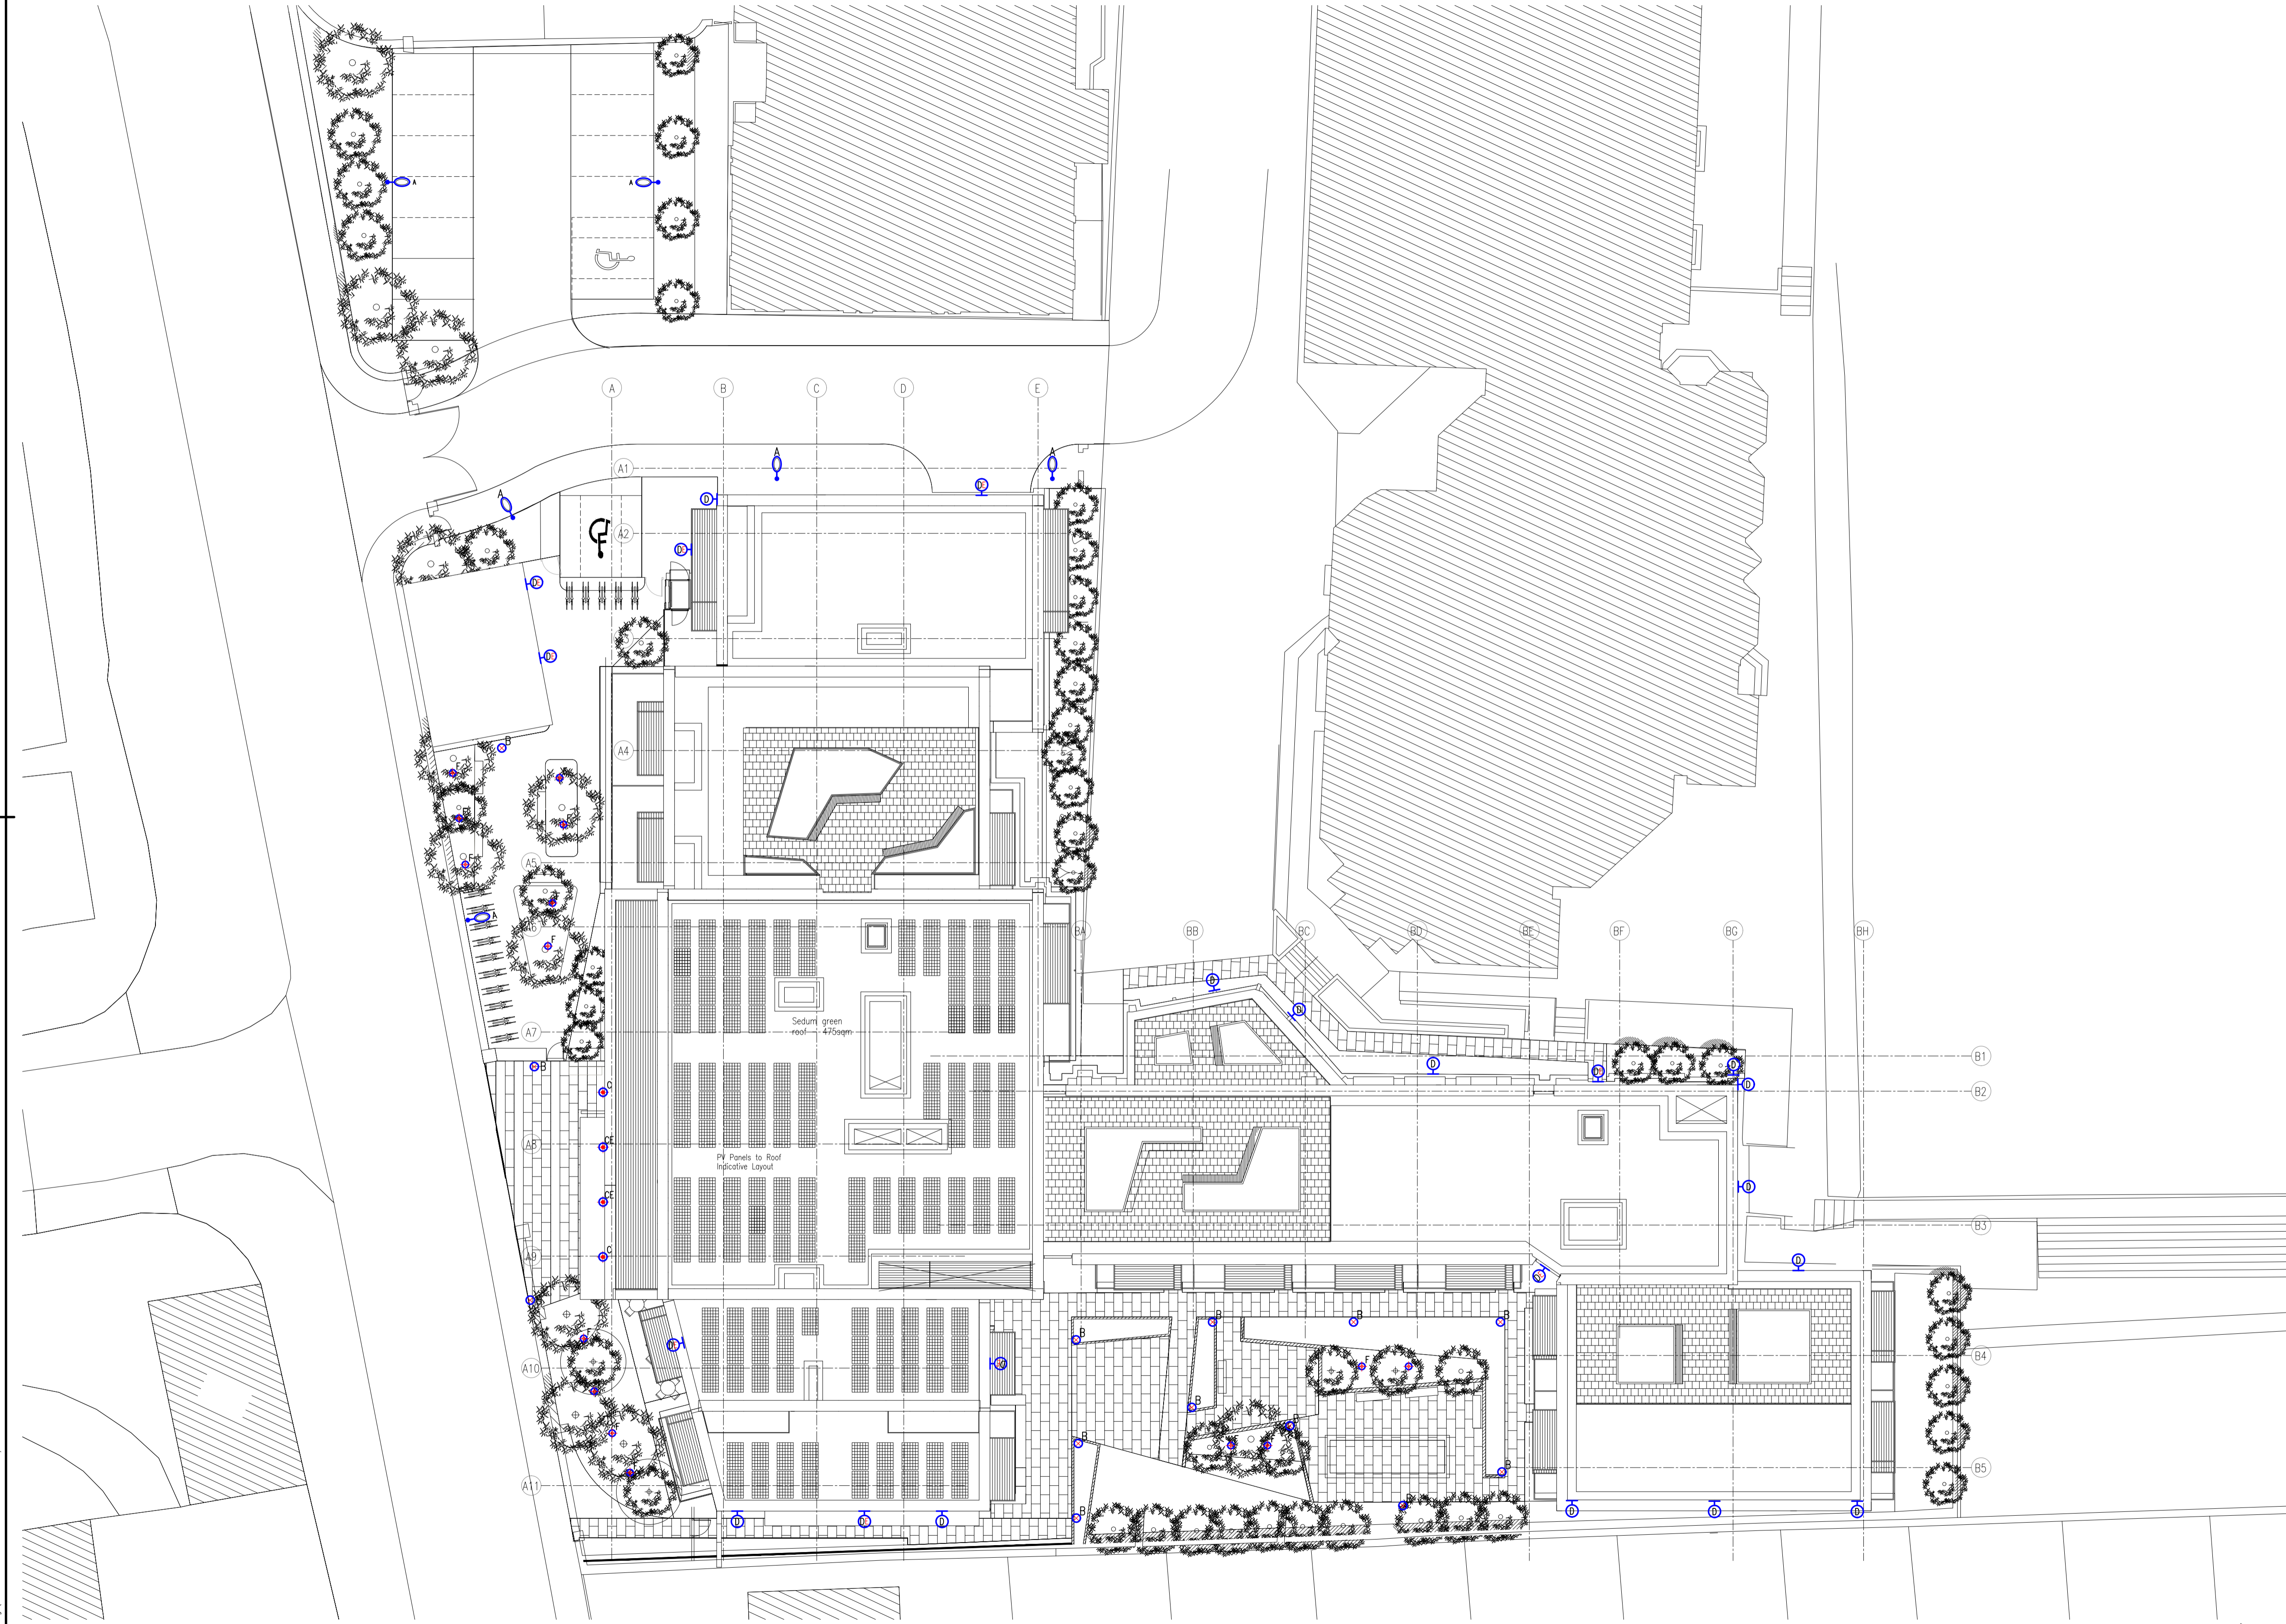

Rev.	Date	Revision Description	Drn.	Chk'd
P2	05.07.22	ISSUED FOR INFORMATION	CM	BS
P1	20.06.22	ISSUED FOR INFORMATION	CM	BS
P	21.10.21	ISSUED FOR INFORMATION	CM	BS

RENAISSANCE ENGINEERING LTD.
 2nd Floor, 67-70 Meath Street, Dublin 8, D08 XY53.
 telephone: +353 (0) 1 675 0850
 email: info@reng.ie
 web: www.renaissanceengineering.ie

Client: **TETARCH RESIDENTIAL LTD.**

Architect: **MCA ARCHITECTS**

Job Title: **STRADBROOK ROAD SHD
BLACKROCK
CO. DUBLIN**

Drawing Title: **PROPOSED SITE LIGHTING LAYOUT**

Date:	Scale:	Job No.:	Drawing No.:	Revision:
21.10.21	1:200	0A1	20-151 63-S0	P2
Designer:	Checked:	Approved:	CAD Filename: 20-151-63-S0.dwg	
CM	BS	SM		